


MATCH-LINE

MATCH-LINE

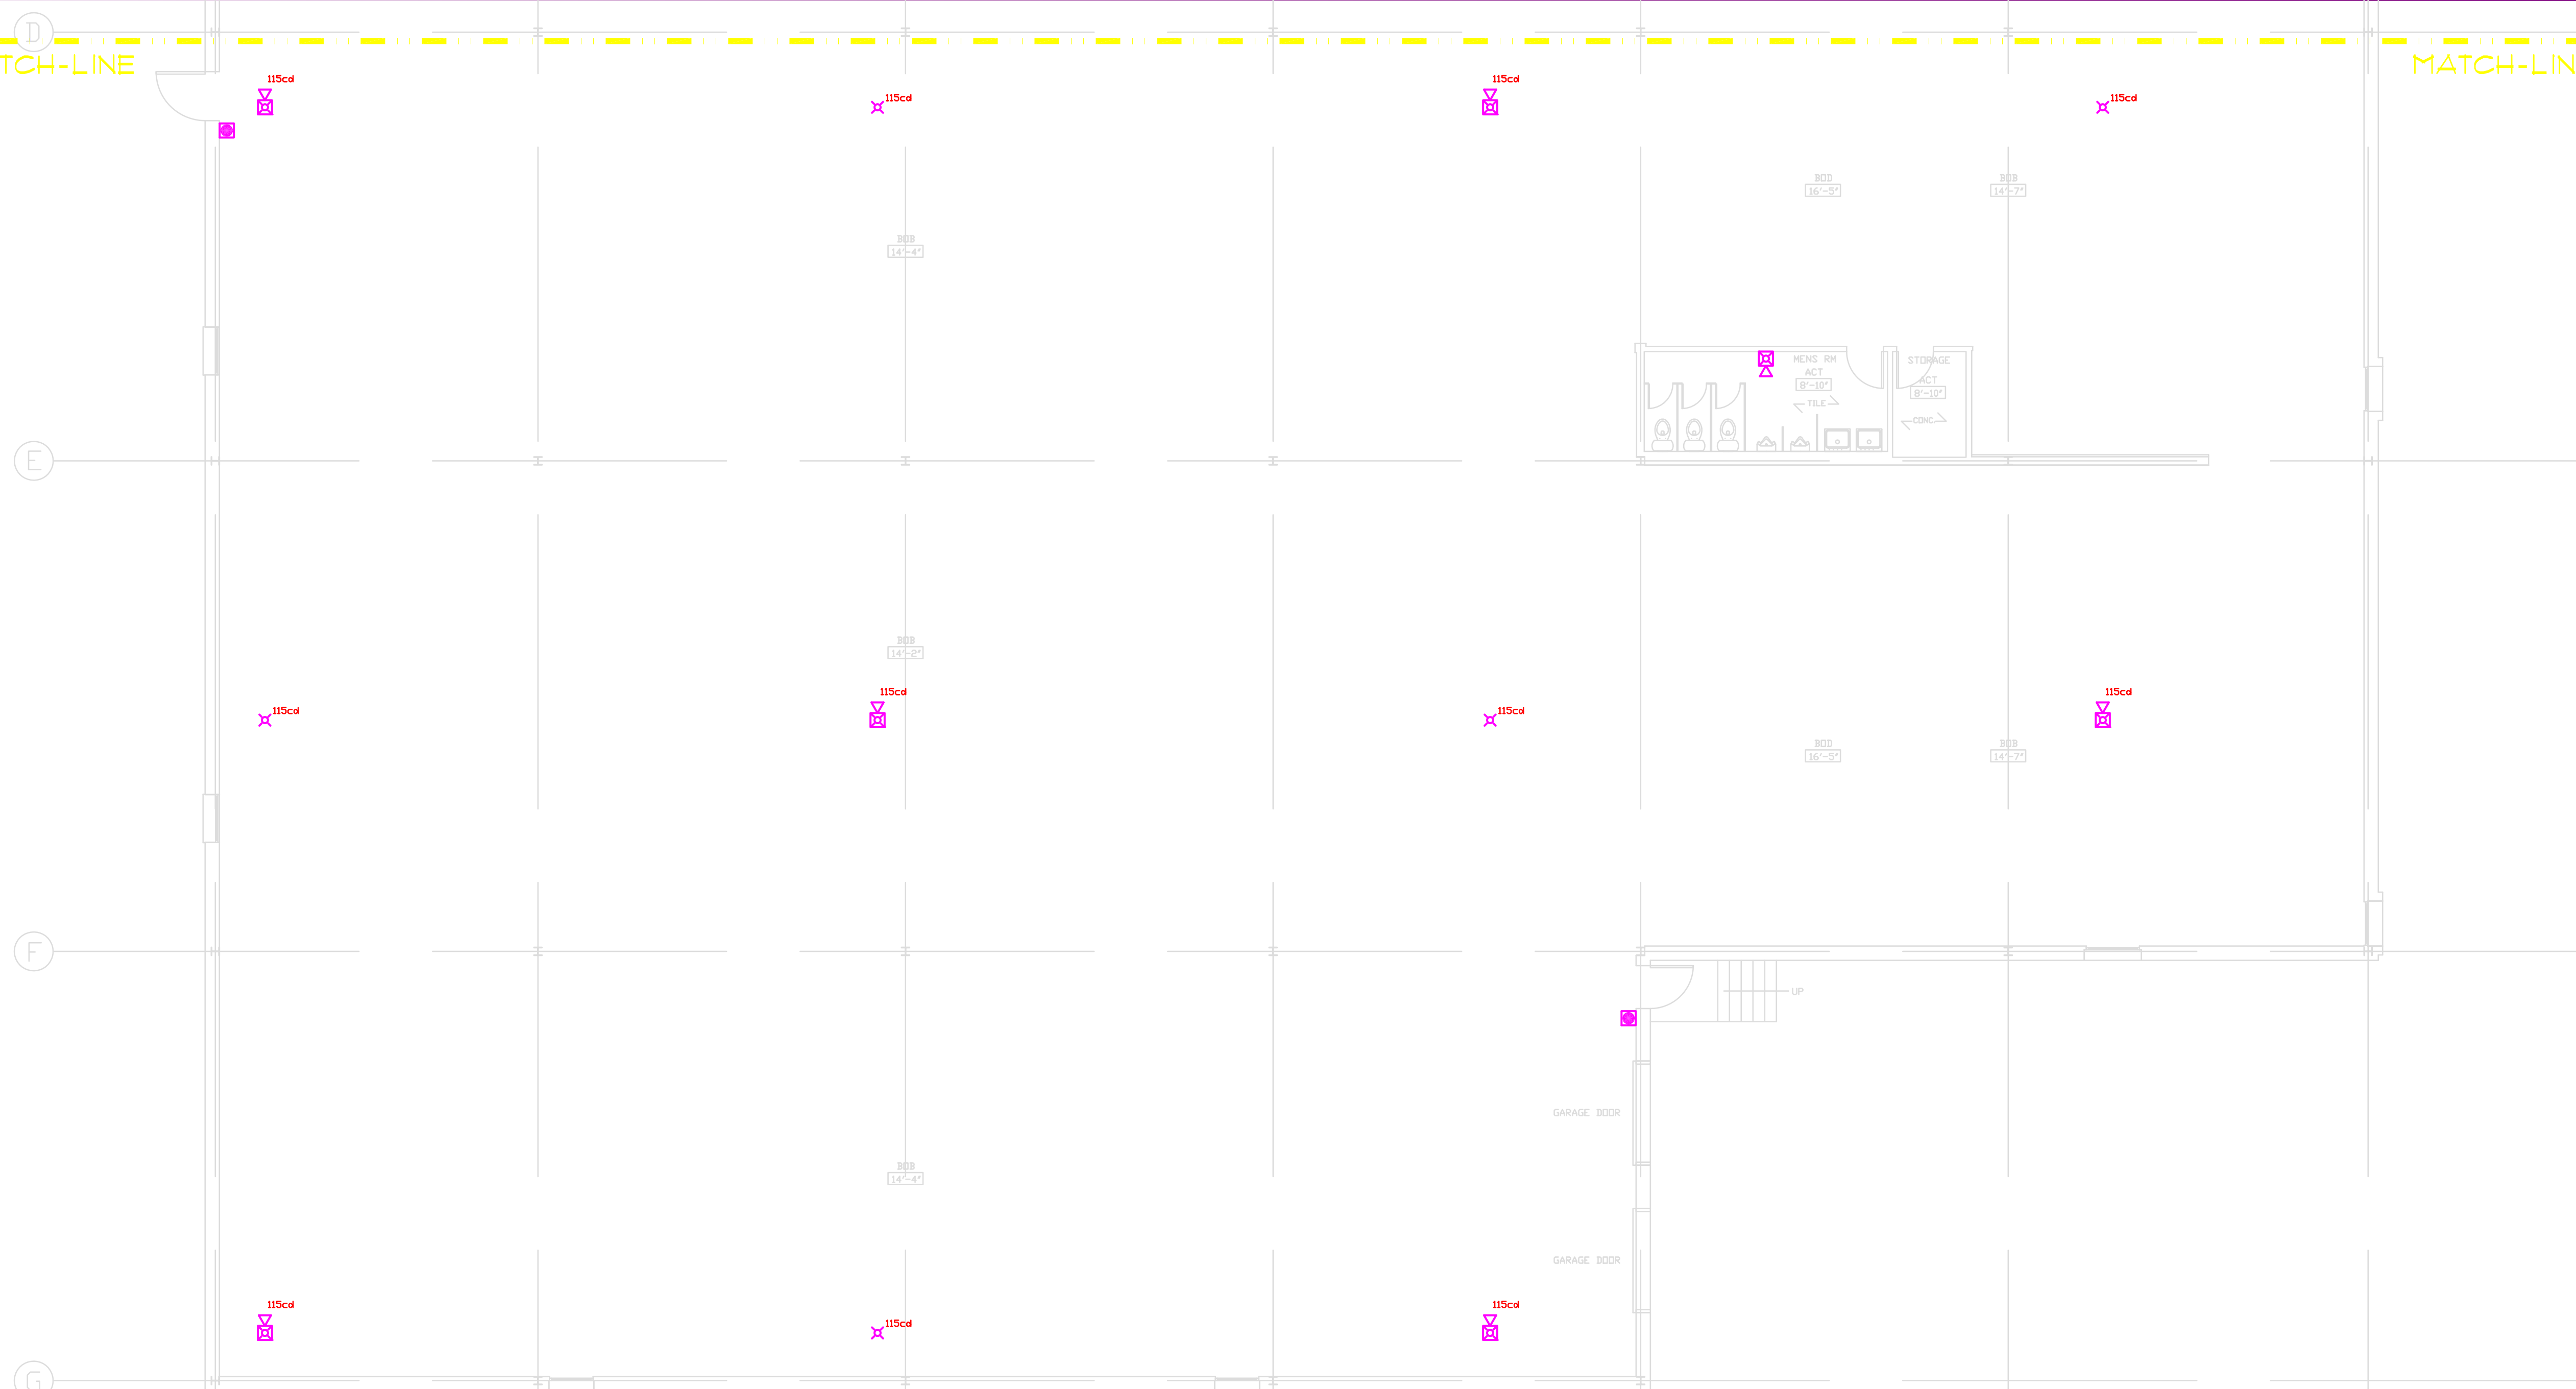

FERNANDEZ & ASSOCIATES
 FIRE PROTECTION ENGINEERS
 63 Larkin Road
 Byfield, Massachusetts 01922
 Telephone 978-499-0172
 Fax 978-465-2371
 Email: fff@fernandezassoc.com

COPYRIGHT 2008 FERNANDEZ & ASSOCIATES
 ALL RIGHTS RESERVED. NO PART OF THIS WORK MAY BE REPRODUCED OR COPIED IN ANY FORM OR BY MEANS - GRAPHIC, ELECTRONIC OR MECHANICAL, INCLUDING PHOTOCOPIING, RECORDING, TAPING, OR INFORMATION AND RETRIEVAL SYSTEMS - WITHOUT WRITTEN PERMISSION OF FERNANDEZ & ASSOCIATES

IT IS A VIOLATION UNDER APPLICABLE LAW FOR ANY PERSON, UNLESS ACTING UNDER THE DIRECTION OF A LICENSED PROFESSIONAL ENGINEER TO ALTER ANY ITEM ON THIS DOCUMENT IN ANY WAY.

NO.	REVISIONS	DATE

PROJECT
 Combustible Liquids
 Warehouse
 Braintree, MA

TITLE
 Fire Alarm
 Layout

DRAWING NO.
 FA-2

LEGEND

- NEW**
- ADDRESSABLE FULL STATION
 - ADDRESSABLE SMOKE DETECTOR
 - STROBE UNIT (15/15 cd)
 - COMBINATION HORN/STROBE UNIT (15/15 cd)
 - CEILING MOUNTED COMBINATION HORN/STROBE UNIT (115 cd)
 - CEILING MOUNTED STROBE UNIT (115 cd)
 - COMBINATION HORN/STROBE UNIT (75 cd)
 - ADDRESSABLE MONITOR MODULE
 - ADDRESSABLE CONTROL MODULE
 - ADDRESSABLE FIRE ALARM CONTROL PANEL
 - 8 AMP REMOTE POWER SUPPLY
- EXISTING TO REMAIN**
- EXISTING LOCAL ENERGY MASTER BOX
 - EXISTING OUTSIDE RED BEACON

NOTES

1. INSTALLATION TO BE IN ACCORDANCE WITH NFPA-72, 2002 EDITION, AMERICANS WITH DISABILITY ACT, MASSACHUSETTS STATE BUILDING & LOCAL CODES, STANDARDS AND ORDINANCES.
2. INSTALL FULL STATIONS AT MAXIMUM HEIGHT OF 48 INCHES ABOVE FINISH FLOOR.
3. INSTALL HORN/STROBES AT MAXIMUM HEIGHT OF 80 INCHES ABOVE FINISH FLOOR OR 6 INCHES BELOW CEILING, WHICHEVER IS LOWER.
4. MEET OTHER REQUIREMENTS OF THE AUTHORITY HAVING JURISDICTION.
5. ALL EXISTING FIRE ALARM EQUIPMENT TO BE REMOVED AFTER NEW SYSTEM HAS BEEN APPROVED.
6. EXISTING MASTER BOX AND OUTSIDE RED BEACON TO REMAIN AND BE RE-CONNECTED TO NEW FIRE ALARM SYSTEM.